


1 EQUIPMENT PLAN
1/4" = 1'-0"

DOOR EQUIPMENT SCHEDULE					
Mark	Count	Function	Model	Description	Hardware
101	2	Exterior		Tel 20 Ga. Steel Door	(2) Deadbolt, (2) Push/Pull Hardware (2) Closer
102	1	Interior	30"x80"	Legacy Walnut w/ Steel Jamb	(1) Keyed Lever

MECHANICAL EQUIPMENT SCHEDULE					
Mark	Count	Model	Description		
301	1	3 TON	3 Ton Wall Hung System w/ 10kW Heat & CRV Kit		
302	4	270 CFM	Exhaust Fan		

PLUMBING FIXTURE SCHEDULE					
Mark	Count	Model	Description		
401	1		Handicap water closet w/tank, bowl, and elongated seat w/ grab bars		
402	5		Standard water closet w/ tank, bowl, & elongated seat		
403	14		Wall Hung Urinal w/ Flush Valve		
404	10		Wall hung lavatory with faucet		
405	1	12 GA	Electric Water Heater		
407	1				
408	1				

FURNITURE EQUIPMENT SCHEDULE					
Mark	Count	Model	Description		
501	13	12"	Urinal Partition		
502	1		Toilet Partition: 4 Standard Stalls, 1 Ambulatory, and 1 ADA Stall		
503	10	18X36	ADA FRAMED MIRROR		

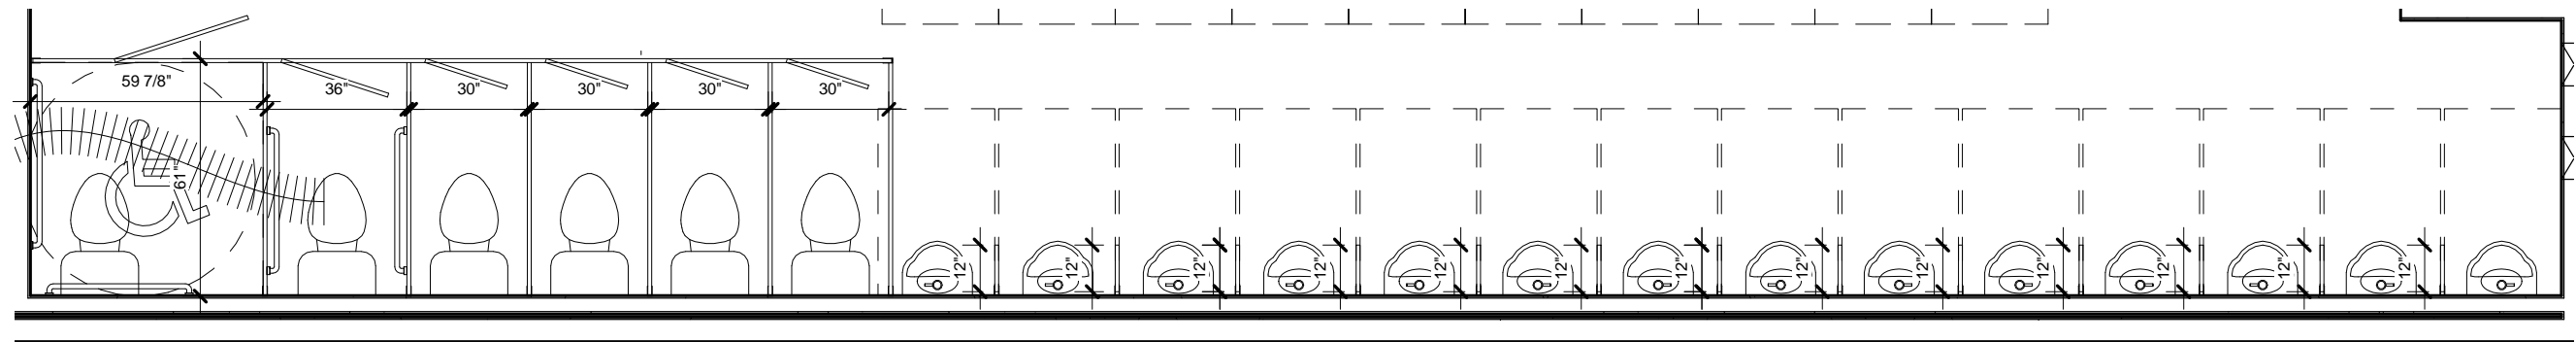

2 PARTITION DETAIL
1/4" = 1'-0"

DATE:	1JULY15	#	DESCRIPTION	BY	DATE	PROJECT TITLE:		
SCALE:	1/4" = 1'-0"	0	ISSUE FOR REVIEW	STR	1JULY15	11'-9" X 56' WASHCAR		
DRAWN BY:	STR					DRAWING TITLE:	PROJECT NO:	SHEET NO:
CHECKER:						EQUIPMENT PAGE	152XX-02	A01
Bid #:	715702-01-R1							